



1901-1ST STAGE SCRUBBER	2001-1ST STAGE SUCTION BOTTLE	2002-1ST STAGE DISCH. BOTTLE	1ST INTERSTAGE COOLER SECTION	1902-2ND STAGE SCRUBBER	2003-2ND STAGE SUCTION BOTTLE	2004-2ND STAGE DISCH. BOTTLE	2ND INTERSTAGE COOLER SECTION	1903-3RD STAGE SCRUBBER	2005-3RD STAGE SUCTION BOTTLE	2006-3RD STAGE DISCH. BOTTLE	AFTERCOOLER COOLER SECTION
30" O.D. x 78' S/S	20" O.D. x 84" S/S	16" O.D. x 144" S/S	IC-1	24" O.D. x 66" S/S	16" O.D. x 36" S/S	16" O.D. x 46" S/S	IC-2	18" O.D. x 66" S/S	14" O.D. x 36" S/S	14" O.D. x 44" S/S	AC
635# MAWP @ 150°F	635# MAWP @ 150°F	635# MAWP @ 350°F	645# MAWP @ 350°F	635# MAWP @ 150°F	635# MAWP @ 150°F	635# MAWP @ 350°F	1292# MAWP @ 350°F	1135# MAWP @ 150°F	1135# MAWP @ 150°F	1440# MAWP @ 350°F	1440# MAWP @ 350°F

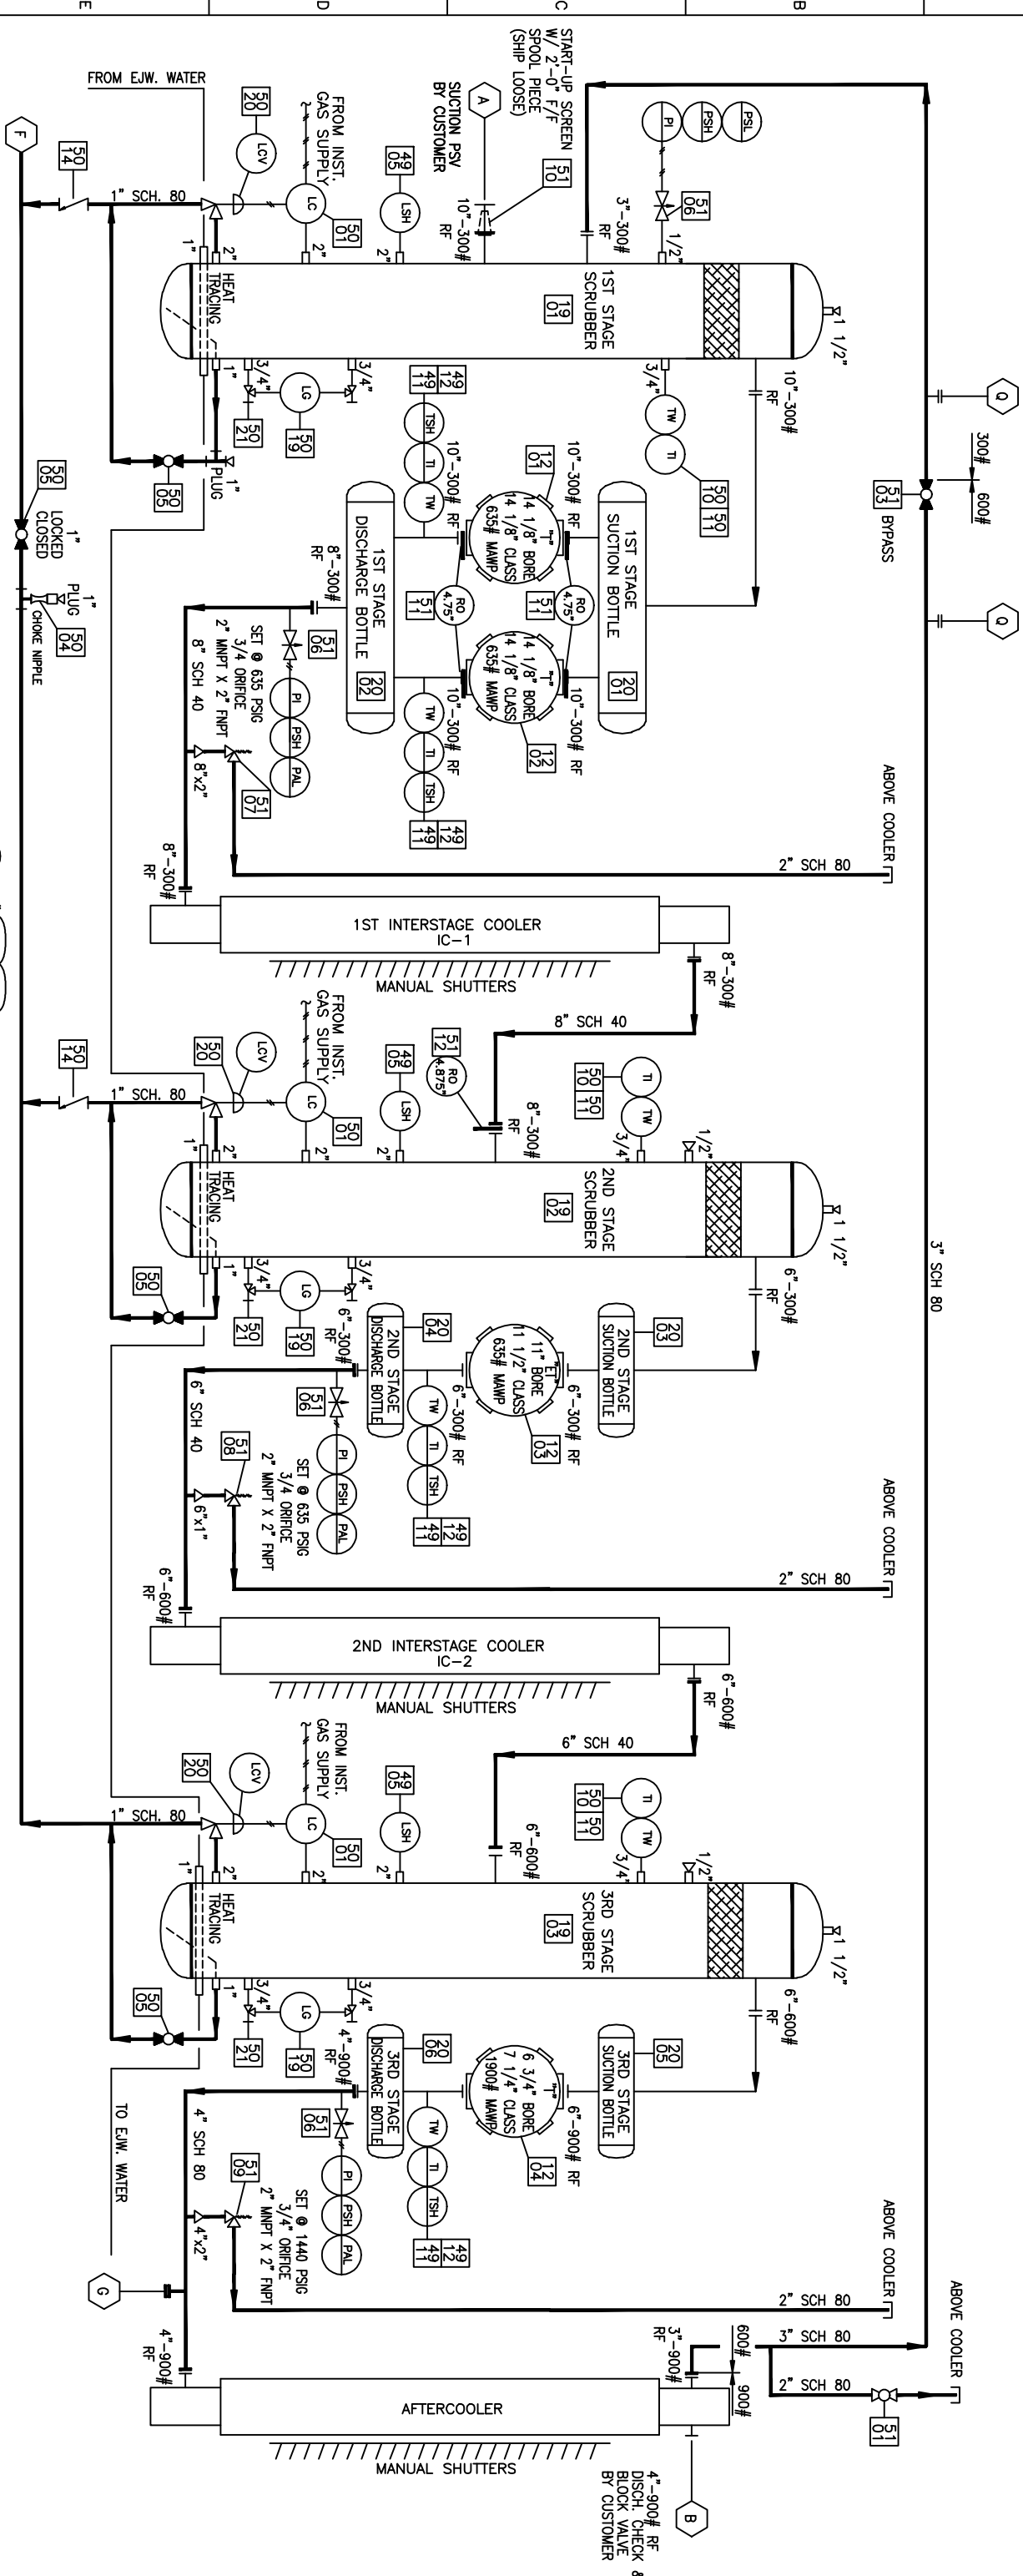

S	ONE	1"	2000#	FNPT	LUBE OIL MAKEUP - COMPRESSOR
P	ONE	2"	2000#	FNPT	START GAS INLET
Q	TWO	2"	2000#	FNPT	FUTURE RECYCLE (PLUGGED)
O	FOUR	2"	3000#	FNPT	SKID DRAIN BOXES
N	ONE	1"	2000#	FNPT	LUBE OIL MAKEUP ENGINE
J	ONE	1"	2000#	FNPT	EJW LOW POINT DRAIN / TAW DRAIN
H	ONE	2"	2000#	FNPT	ENGINE AND COMPRESSOR OIL DRAIN
G	ONE	3"	900#	RFWN	FUTURE DISCHARGE NOZZLE
F	ONE	1"	2000#	FNPT	SCRUBBER DRAIN HEADER
E	ONE	2"	2000#	FNPT	FUEL GAS INLET
B	ONE	4"	900#	RFWN	UNIT DISCHARGE
A	ONE	12"	300#	RFWN	UNIT INLET
MARK	QUAN.	SIZE	RATING	TYPE	SERVICE

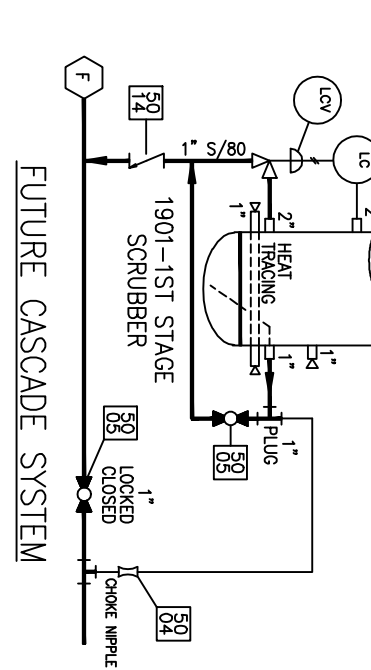

PROPRIETARY AND CONFIDENTIAL
Property of SEC. Drawings are supplied solely to assist in installation, operation and maintenance of SEC supplied equipment. Do not show, distribute or provide to any third party, unless for these purposes. ANY 3rd PARTY USING DRAWINGS IMPROPERLY WILL BE SUBJECT TO CLAIMS BY SEC.
(C) SEC. 2007

DO NOT SCALE DRAWING

REV	DESCRIPTION	DATE
0	ISSUED FOR CONSTRUCTION	5/16/07

MAJOR EQUIPMENT	COMPRESSOR - ARIEL JGT/4
	(2) 14 1/8" T CYL (14 1/8" BORE)
	(1) 11 1/2" ET CYL (11" BORE)
	(1) 7 1/4" T CYL (6 3/4" BORE)
	ENGINE - CATERPILLER 3516
	COUPLING - TB WOODS 70-26-FSH
	COOLER - AIR-X-CHANGERS 156-EH
	PANEL - ALTRONIC

JOB SCOPE PART NUMBER 7003516211

COMPRESSOR PROCESS
P & ID
MIDCON

CUSTOMER CONNECTION SCHEDULE

REV	DESCRIPTION	DATE
0	ISSUED FOR CONSTRUCTION	5/16/07

DRAWN BY:	T. ALLEN
CHECKED BY:	SCALE: NONE

JOB No. STD
JOB No. 07/24/05

DATE: 07/24/05

SCALE: NONE

JOB No. STD-100-01

SHEET 1 OF 3

REV 0